


Appendix C-2

- LEGEND
- CONTROL PANEL
 - SMOKE DETECTOR
 - PULL STATION
 - HEAT DETECTOR
 - WATERFLOW
 - TAMPER
 - ANSUL CONNECT
 - HORN
 - HORN/STROBE
 - STROBE


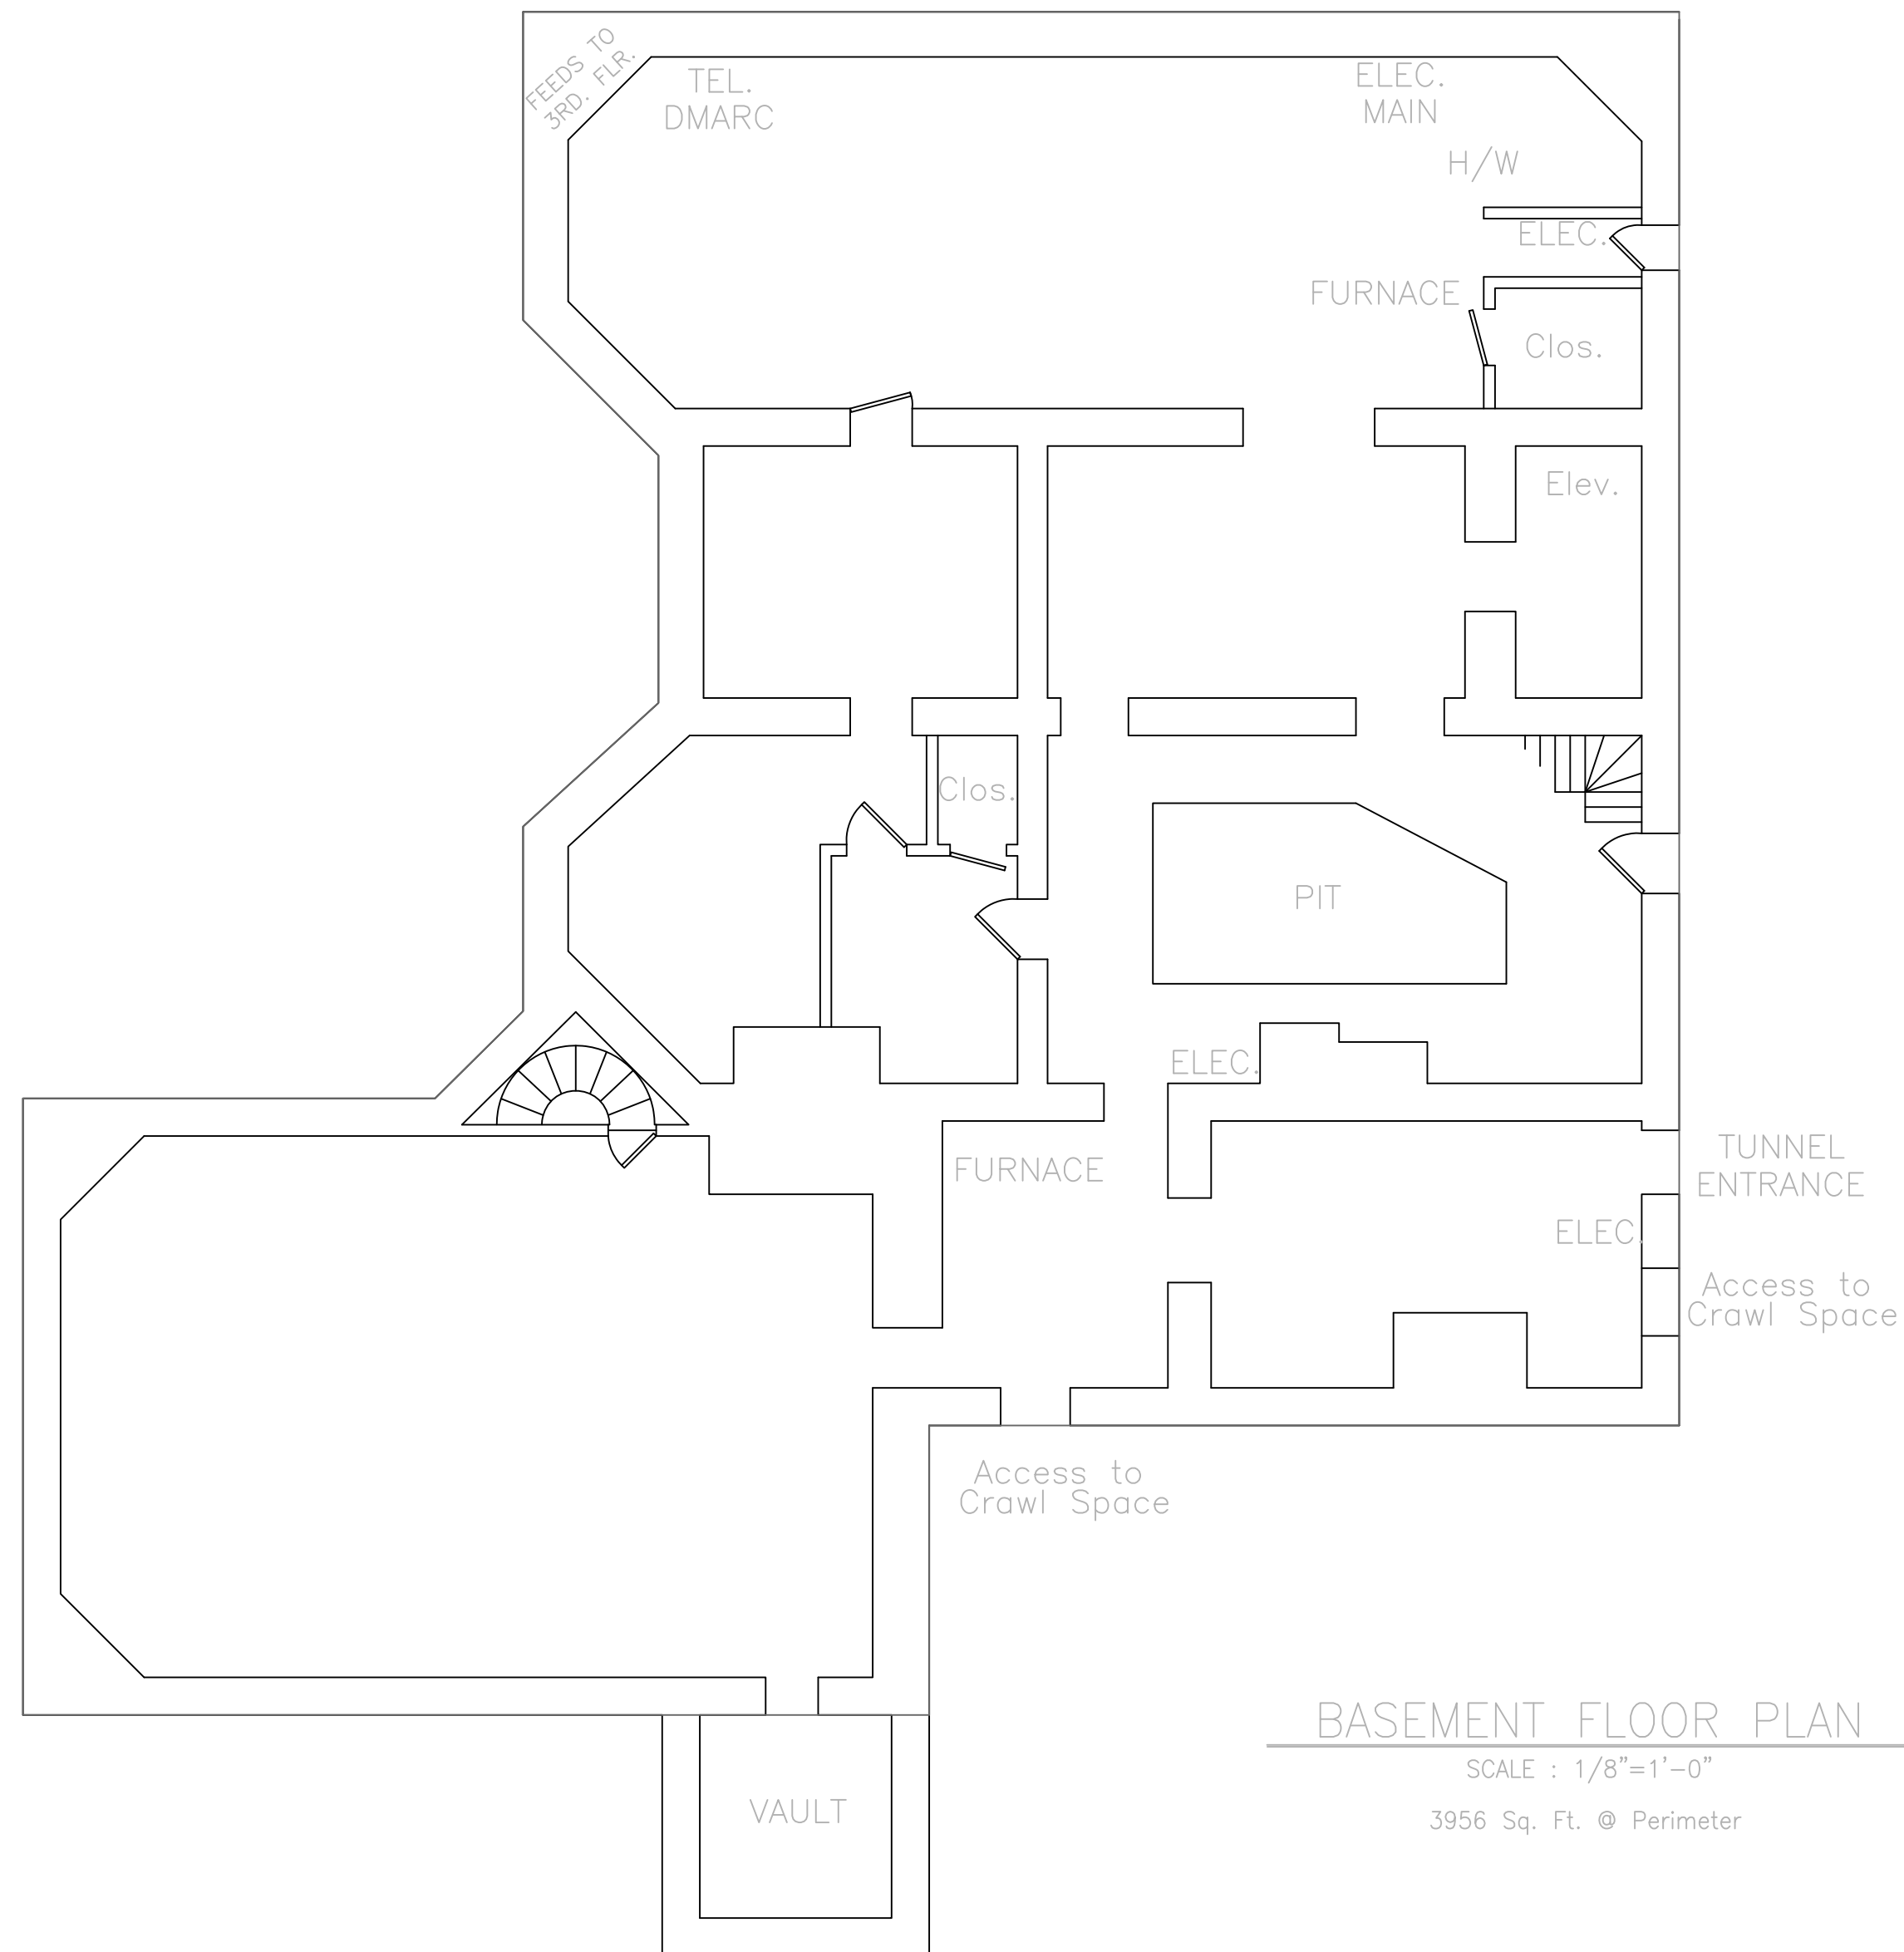


BASEMENT FLOOR PLAN

SCALE : 1/8"=1'-0"

3956 Sq. Ft. @ Perimeter

BELLEVUE MANOR HOUSE			
DRAWN: SJK	CHECKED:	REVISED: 4/19/99	SHEET #
DATE: 1/23/99	APPRVD:	SCALE: SHOWN	1 OF 4

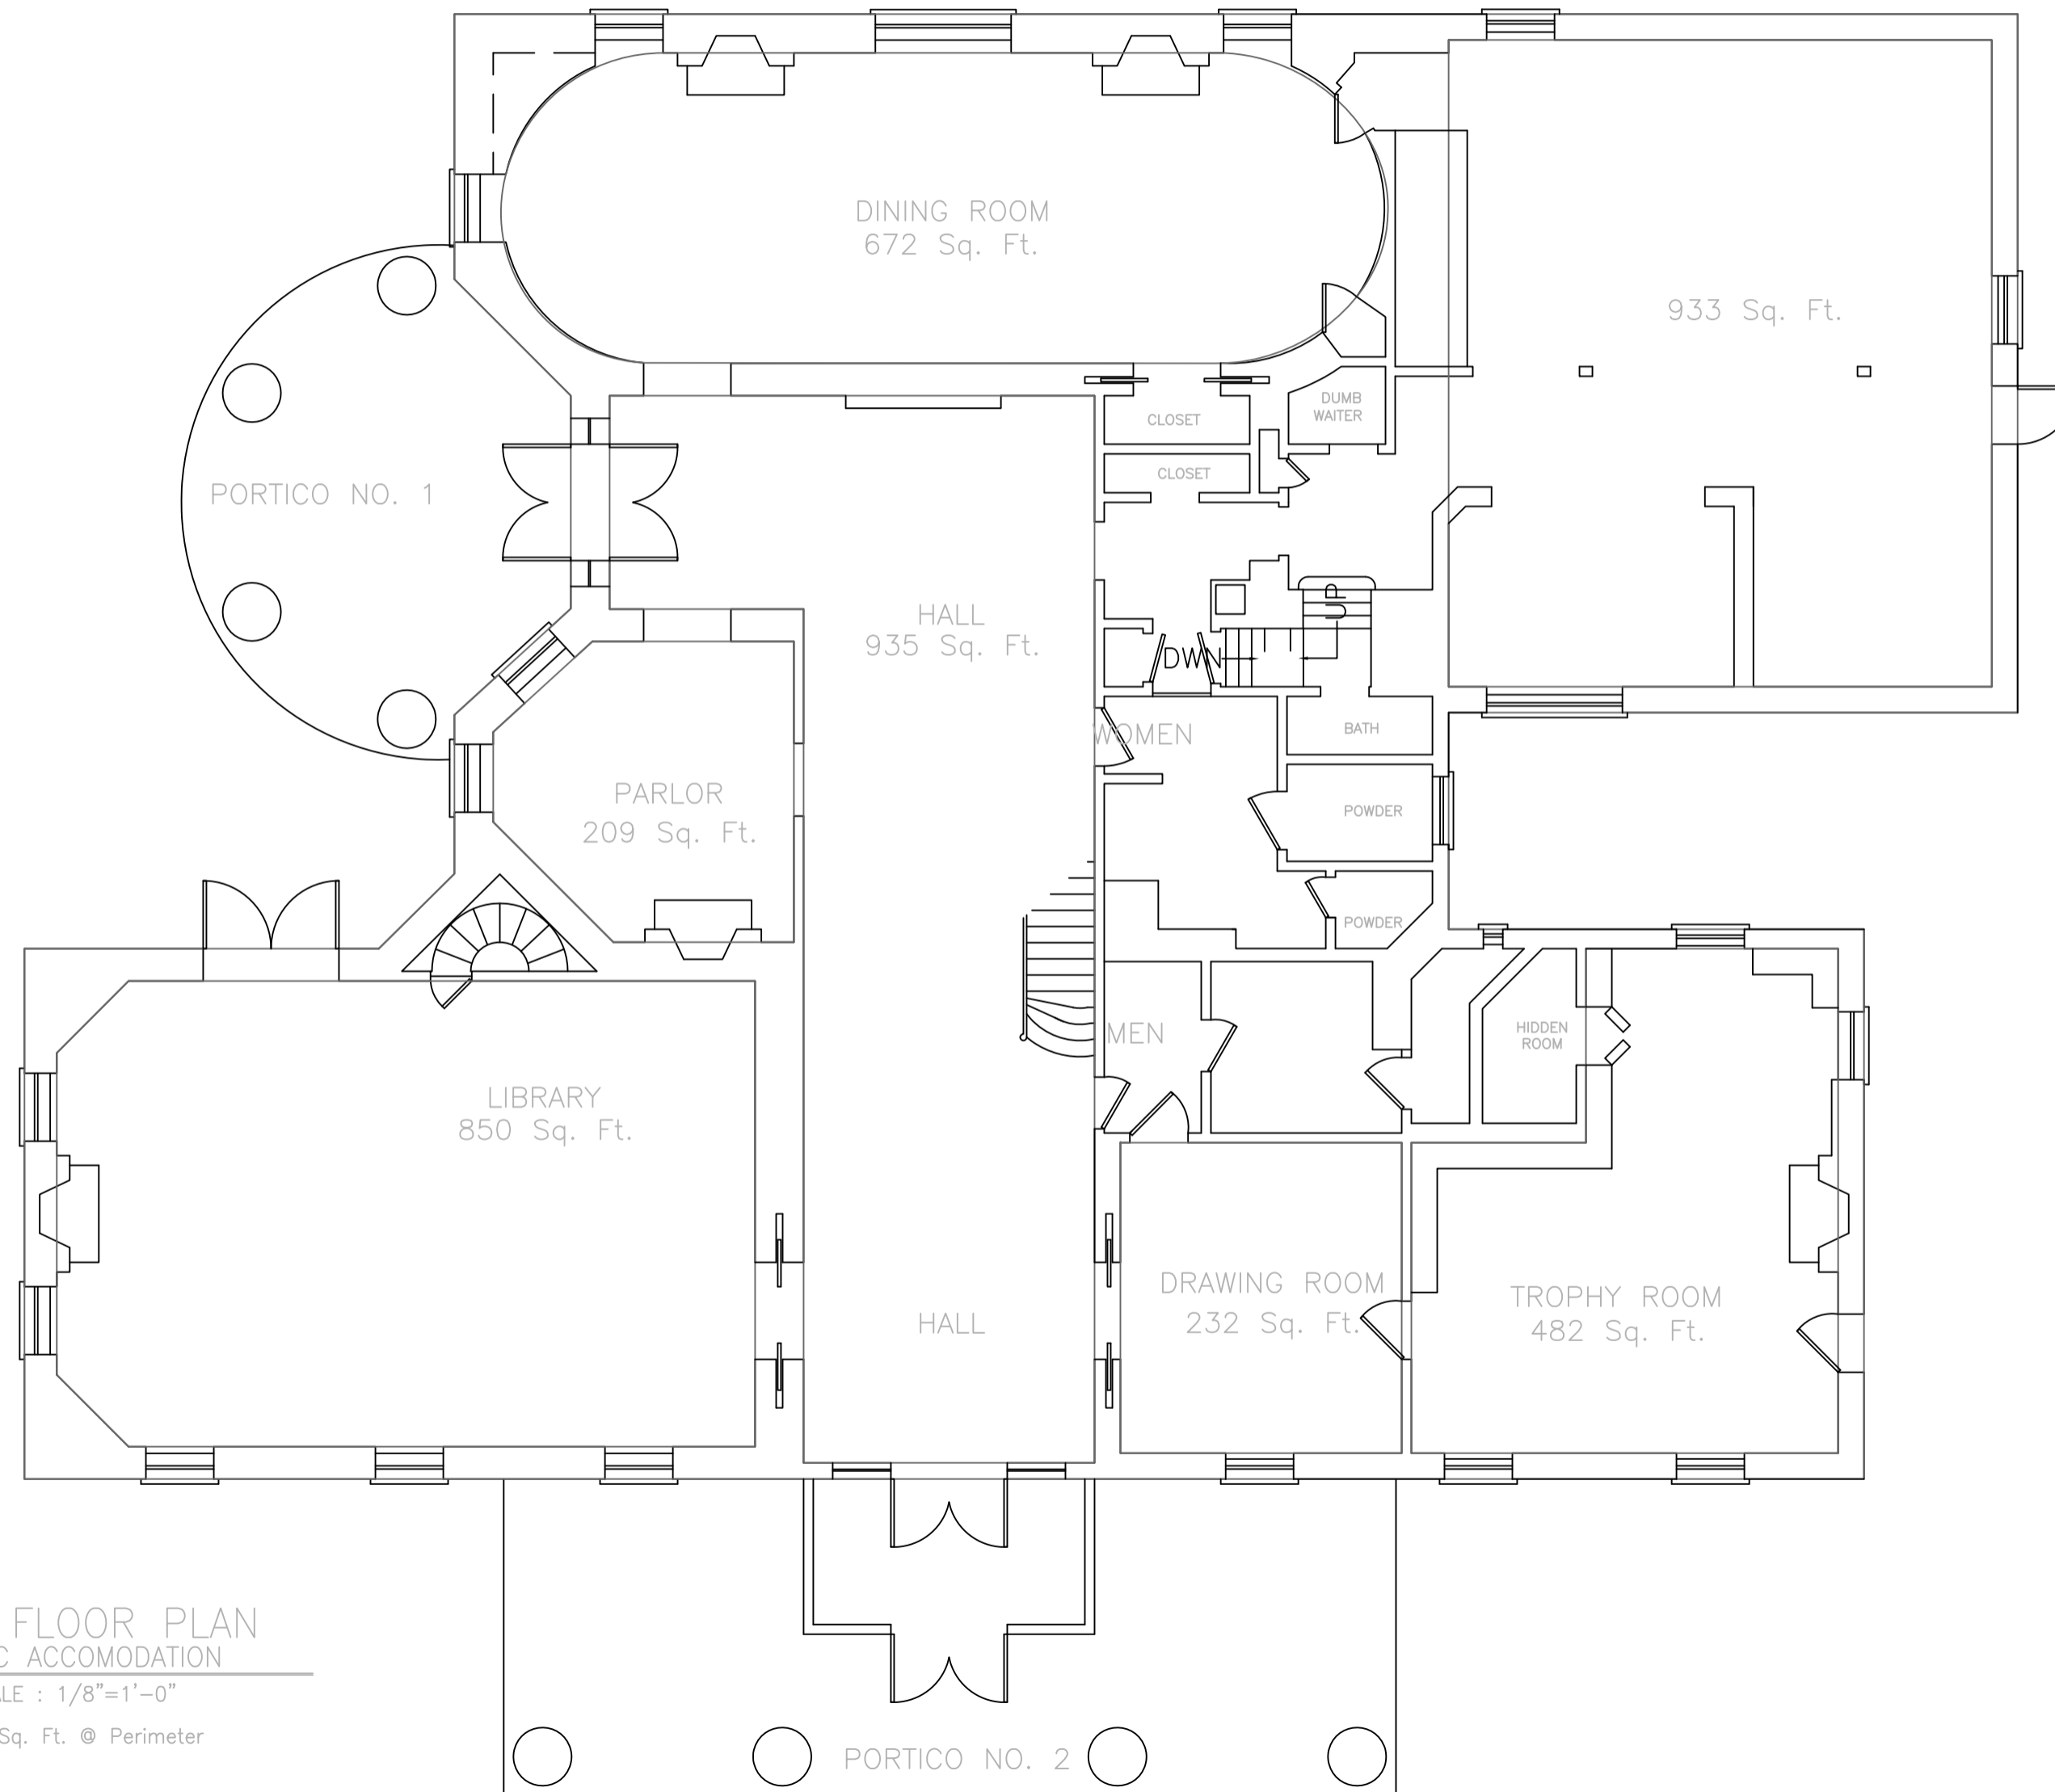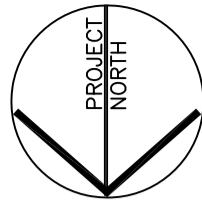

- LEGEND**
- CONTROL PANEL
 - SMOKE DETECTOR
 - PULL STATION
 - HEAT DETECTOR
 - WATERFLOW
 - TAMPER
 - ANSUL CONNECT
 - HORN
 - HORN/STROBE
 - STROBE
 - BEAM DETECTOR
 - REMOTE ANNUNCIATOR
 - BEAM DETECTOR



FIRST FLOOR PLAN
PUBLIC ACCOMODATION

SCALE : 1/8"=1'-0"

6045 Sq. Ft. @ Perimeter

BELLEVUE MANOR HOUSE

DRAWN: SJK	CHECKED:	REVISED: 4/19/99	SHEET #
DATE: 1/26/99	APPRVD:	SCALE: SHOWN	2 OF 4

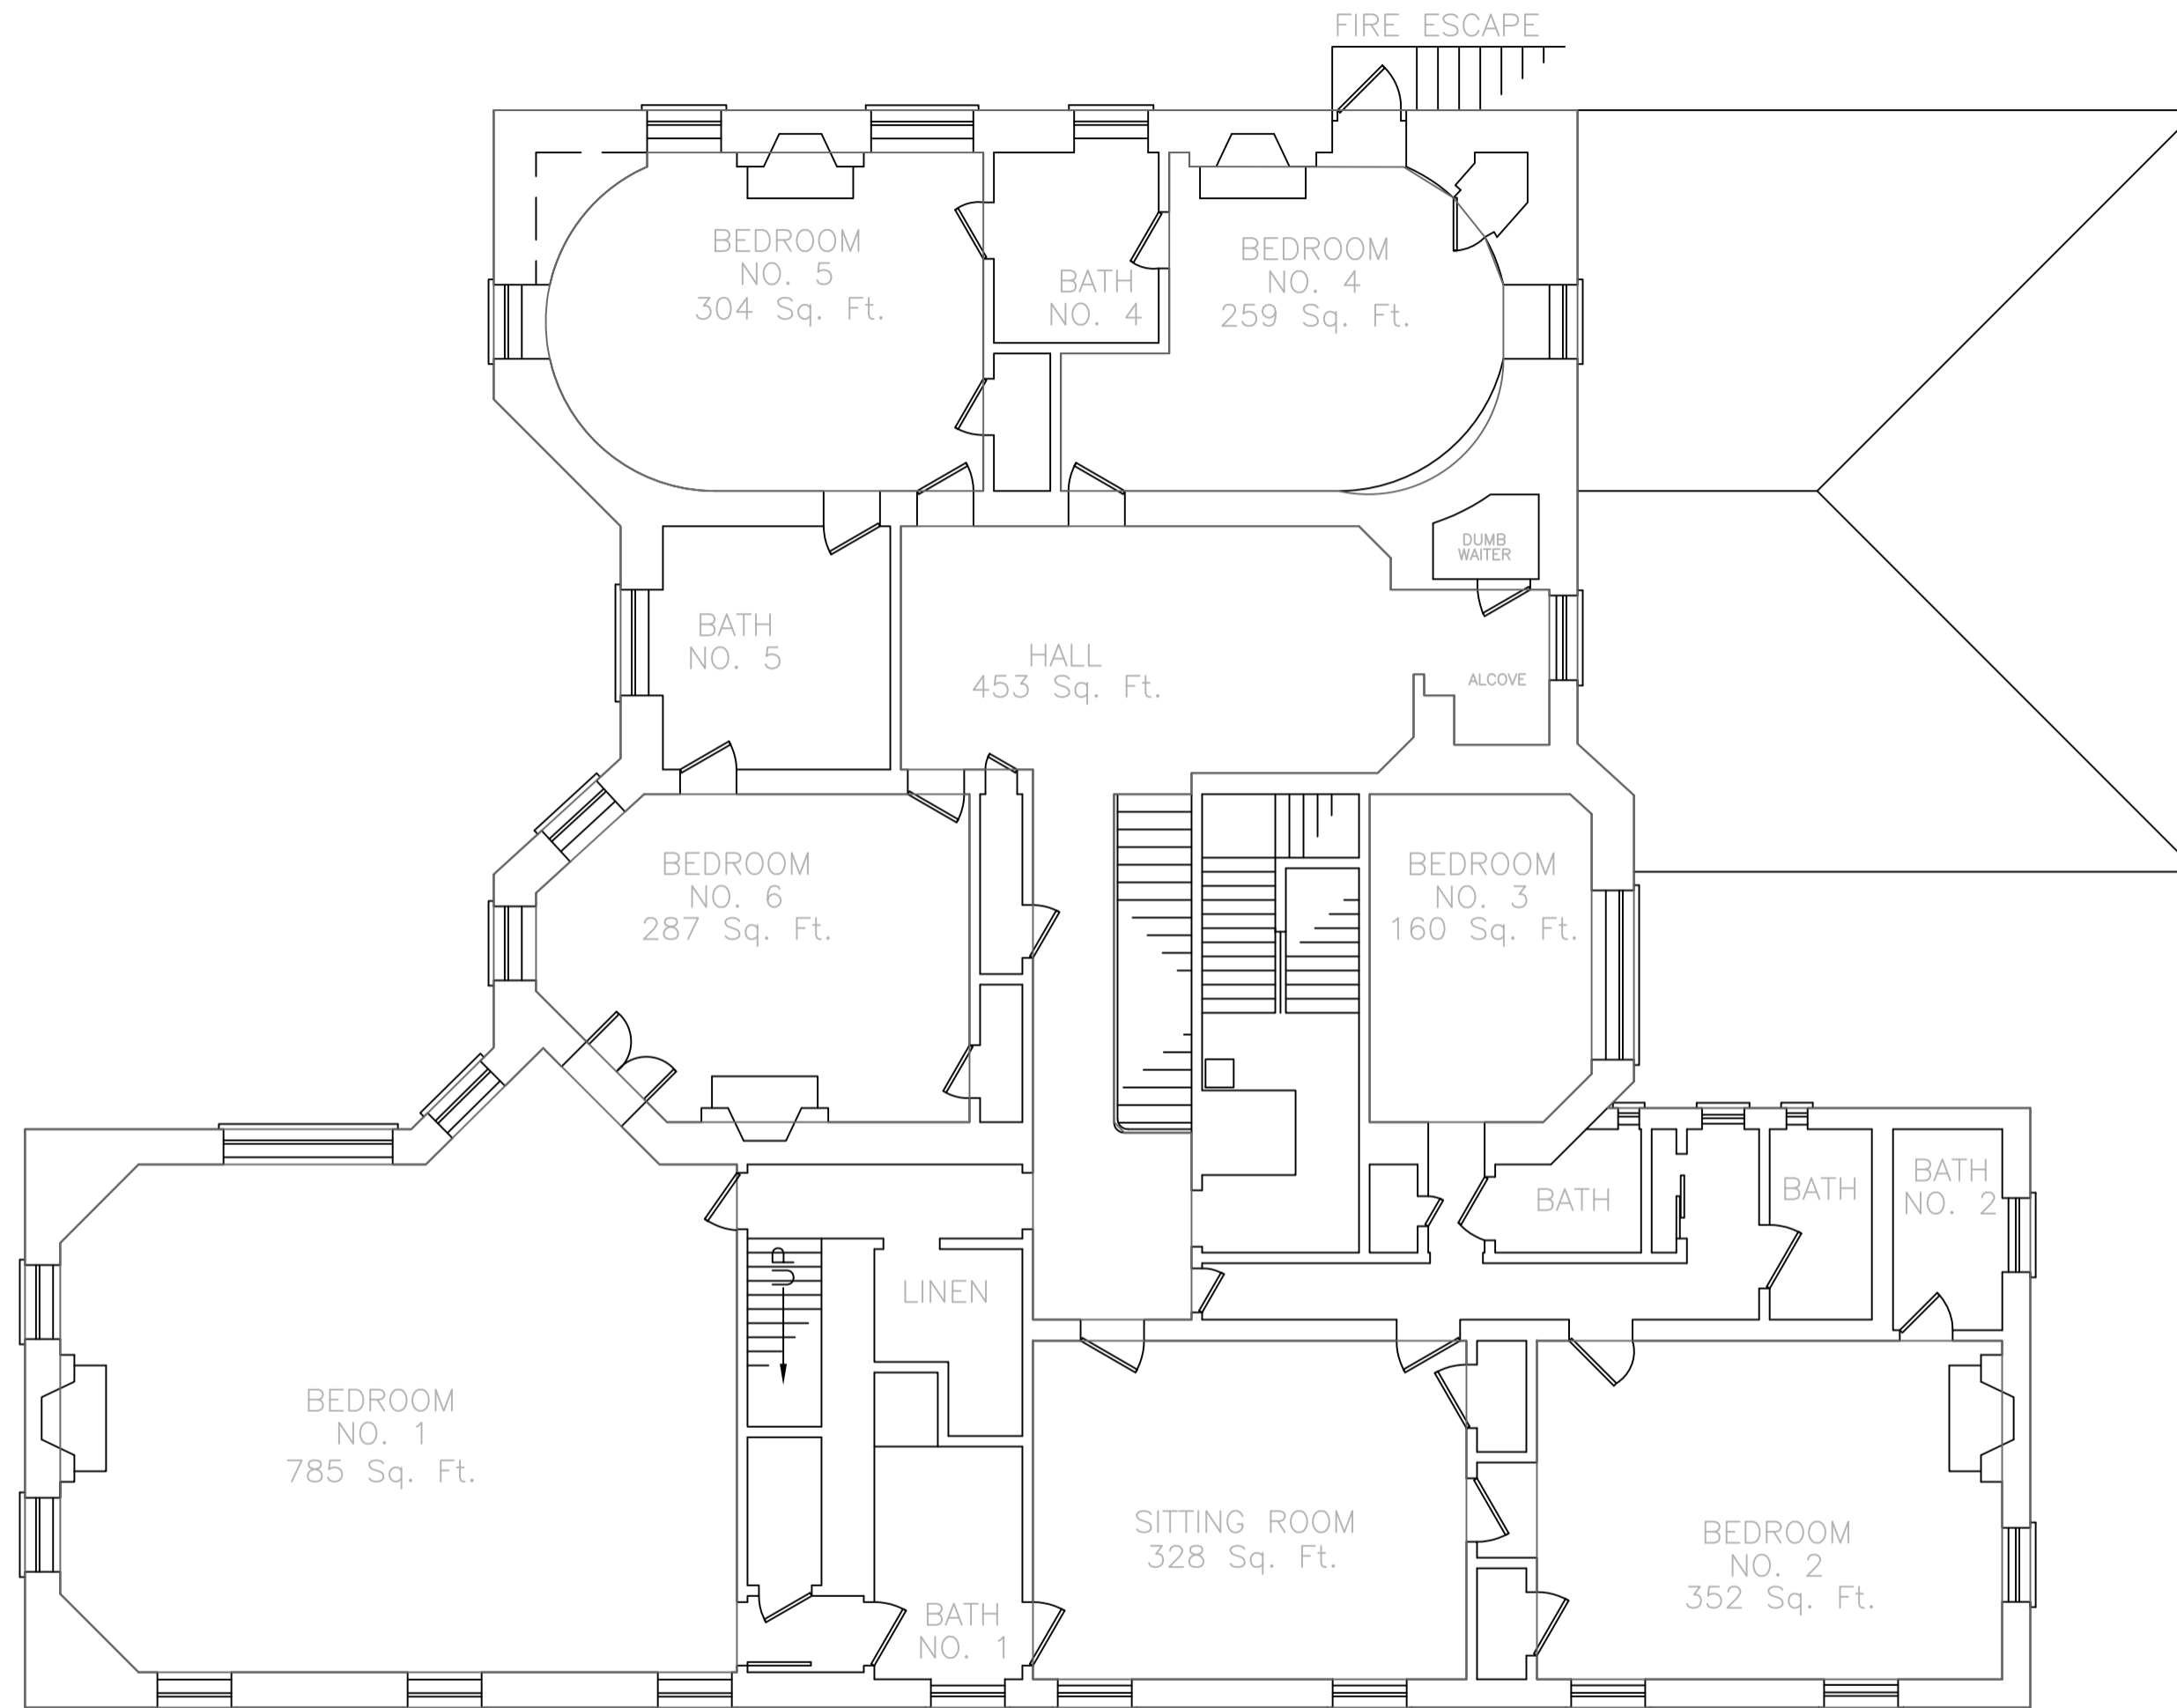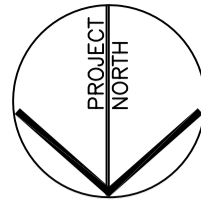

- LEGEND
- CONTROL PANEL
 - SMOKE DETECTOR
 - PULL STATION
 - HEAT DETECTOR
 - WATERFLOW
 - TAMPER
 - ANSUL CONNECT
 - HORN
 - HORN/STROBE
 - STROBE



SECOND FLOOR PLAN
PARTIAL PUBLIC ACCOMODATION

SCALE : 1/8"=1'-0"

5031 Sq. Ft. at Perimeter

BELLEVUE MANOR HOUSE

DRAWN: SJK	CHECKED:	REVISED: 4/19/99	SHEET #
DATE: 1/29/99	APPRVD:	SCALE: SHOWN	3 OF 4

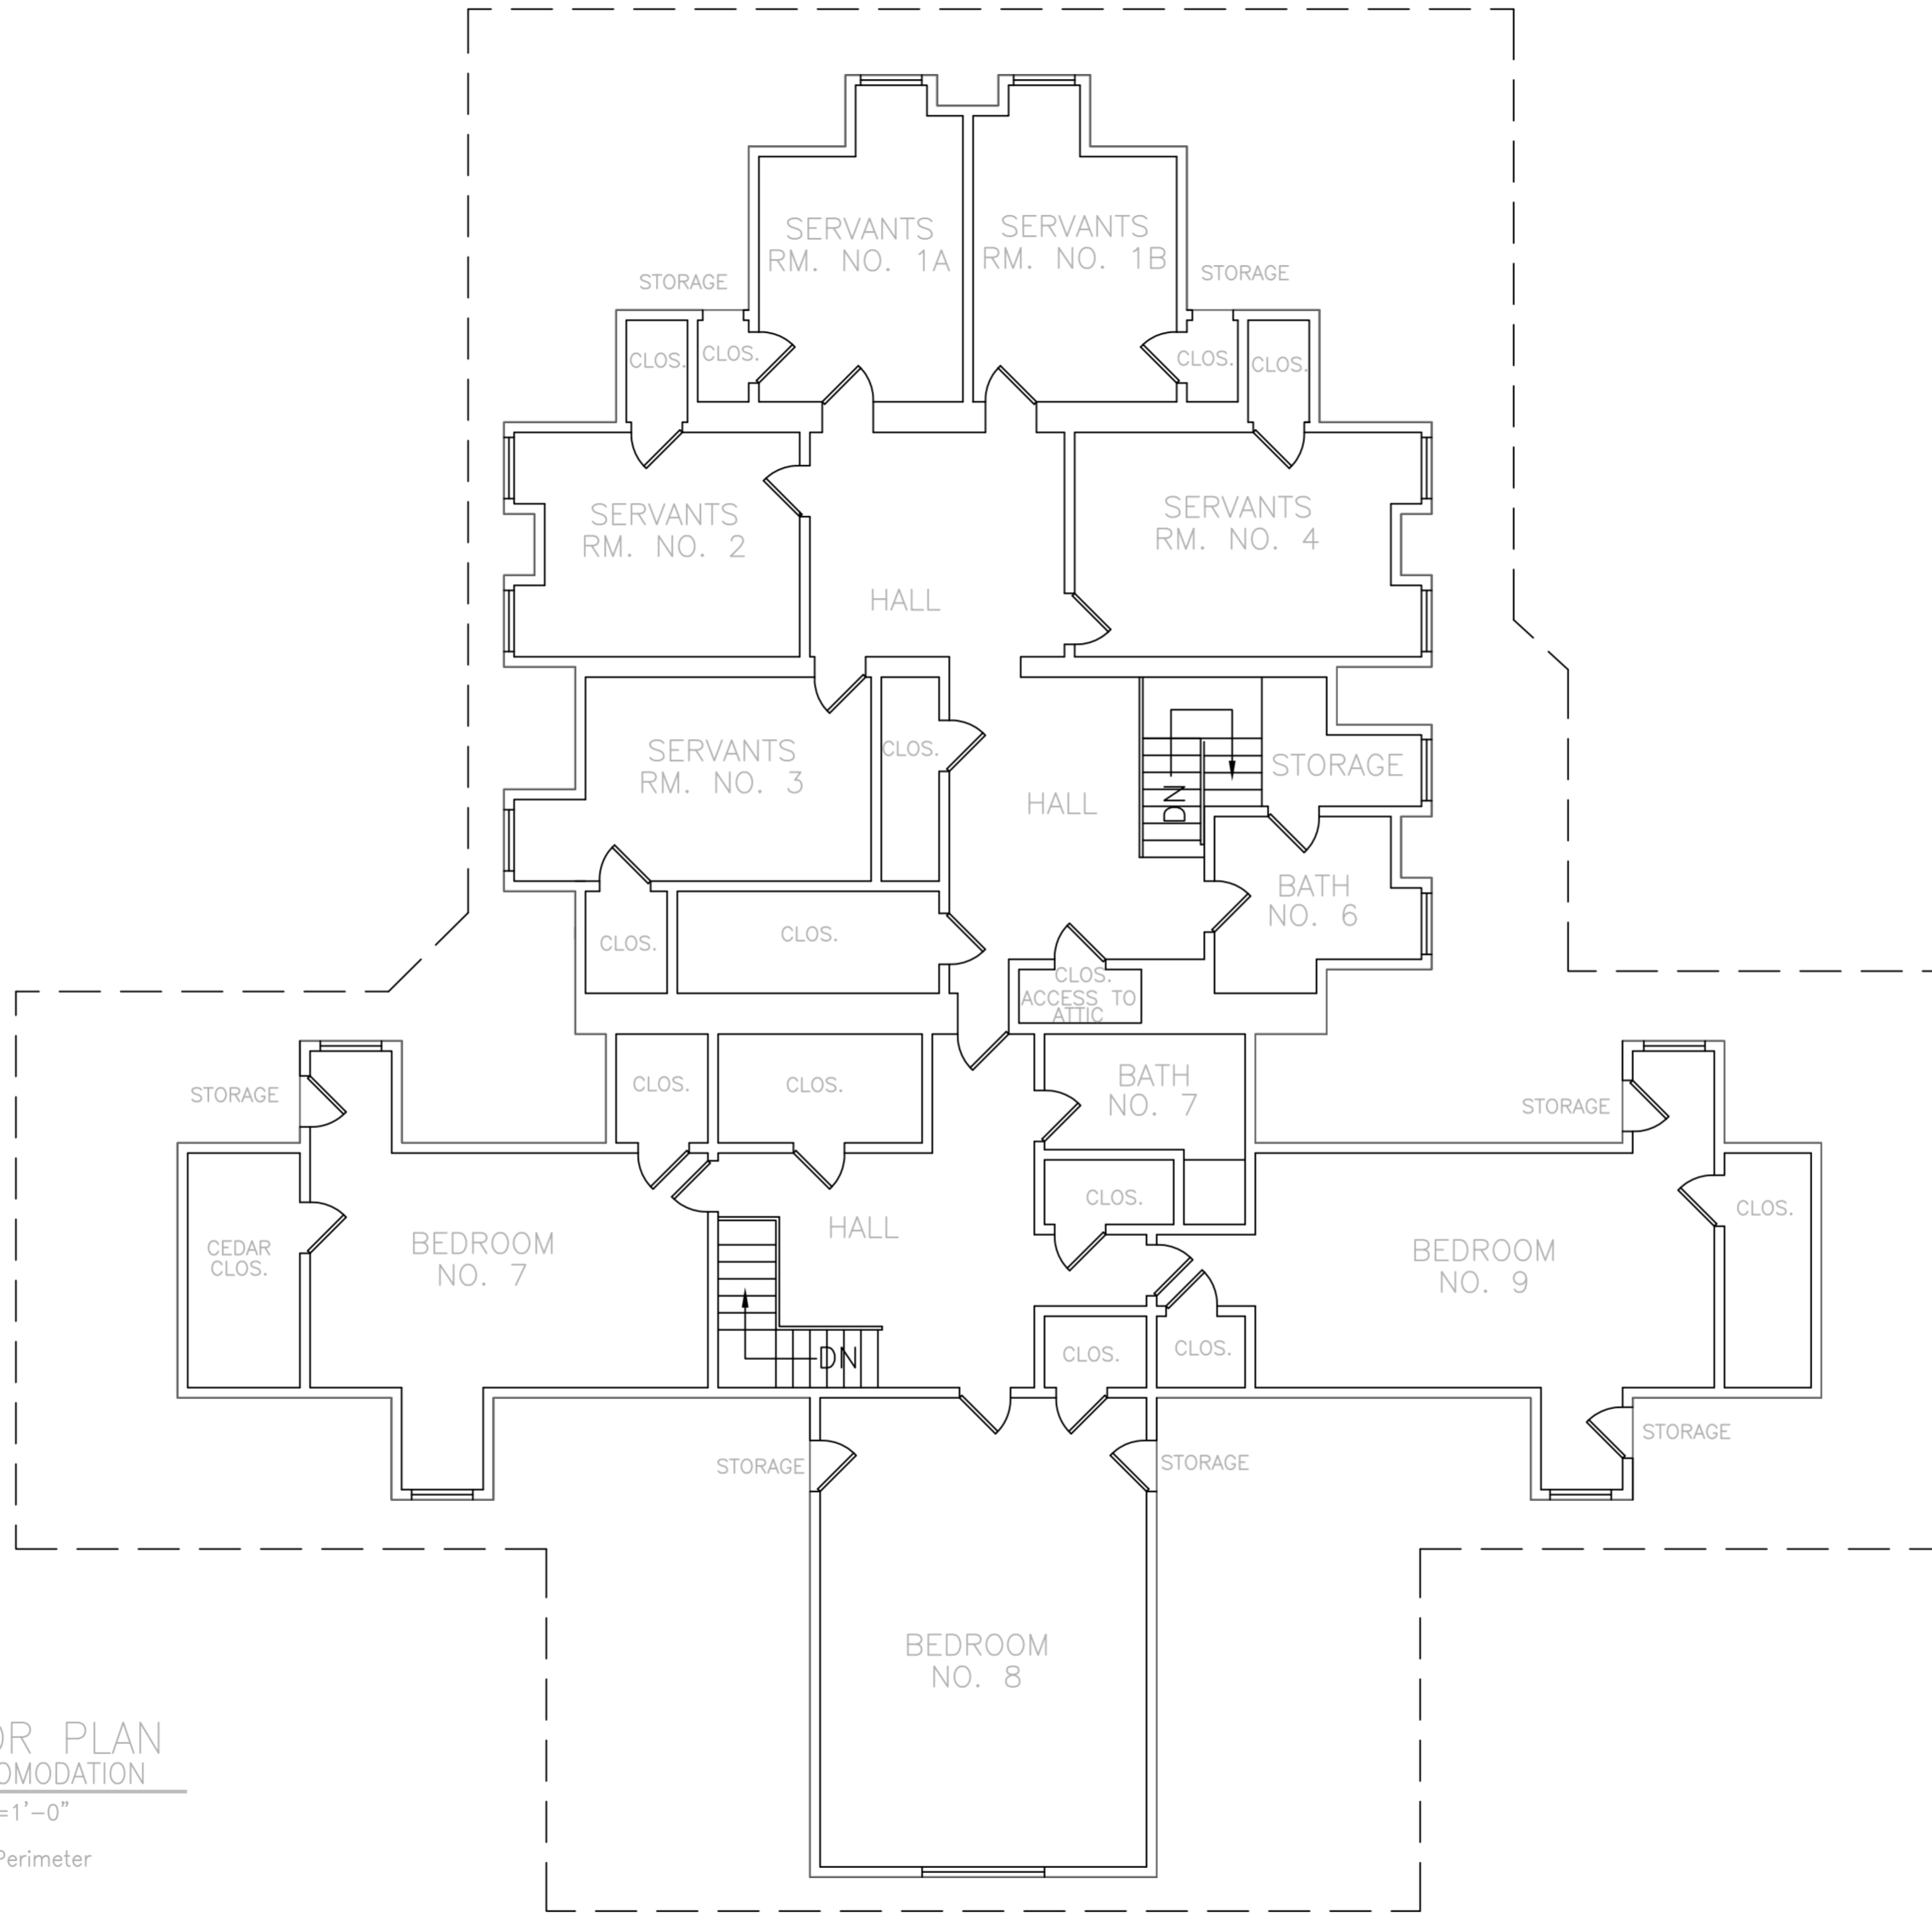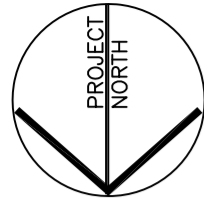

- LEGEND
- CONTROL PANEL
 - SMOKE DETECTOR
 - PULL STATION
 - HEAT DETECTOR

 - WATERFLOW

 - TAMPER
 - ANSUL CONNECT

 - HORN

 - HORN/STROBE

 - STROBE

THIRD FLOOR PLAN
NO PUBLIC ACCOMODATION

SCALE : 1/8"=1'-0"

3352 Sq. Ft. at Perimeter

BELLEVUE MANOR HOUSE

DRAWN: SJK	CHECKED:	REVISED: 4/19/99	SHEET # 4 OF 4
DATE: 2/6/99	APPRVD:	SCALE: SHOWN	